


CONSTRUCTION NOTES - THESE NOTES APPLY TO COCHRANE LOCATION

- N01 PROVIDE PENETRATIONS FOR NEW FLOOR DRAIN, REFER TO MECHANICAL
- N02 PROVIDE AND INSTALL NEW WASHROOM ACCESSORIES.
- N03 PROVIDE AND INSTALL NEW PLUMBING FIXTURES, TYP. REFER TO MECHANICAL
- N04 INSTALL NEW MILLWORK AND COUNTERTOP. REFER TO MILLWORK DETAILS
- N05 TV PROVIDED BY OWNER, INSTALLED BY CONTRACTOR. PROVIDE SOLID WOOD BLOCKING WITHIN WALL ASSEMBLY TO APPROPRIATE METHODS FOR SUPPORTING TV WALL MOUNT. REFER ALSO TO ELECTRICAL FOR CONNECTIONS.
- N06 SECURED MERCHANDISE DISPLAY CASE, REFER TO MILLWORK ELEVATIONS
- N07 DESIGNATED ACCESSIBLE SPACE.
- N08 REINSTALL SALVAGED BOTTLE FILLER/DRINKING FOUNTAIN - PROVIDE ALL ASSOCIATED WORK TO SUIT REINSTALLATION, REFER TO MECHANICAL AND ELECTRICAL
- N09 FOR NEW FURNITURE, REFER TO FURNITURE SCHEDULE AND SPECIFICATIONS
- N10 EXISTING ATM MACHINE TO REMAIN, ALLOW FOR RELOCATION AND REINSTALLATION TO SUIT CONSTRUCTION
- N11 PROVIDE CLEAN TRANSITION BETWEEN FLOOR FINISHES AT THIS DOOR.
- N14 REINSTALL SALVAGED WALL MOUNT TOILET FIXTURE, REFER ALSO TO MECHANICAL DRAWINGS

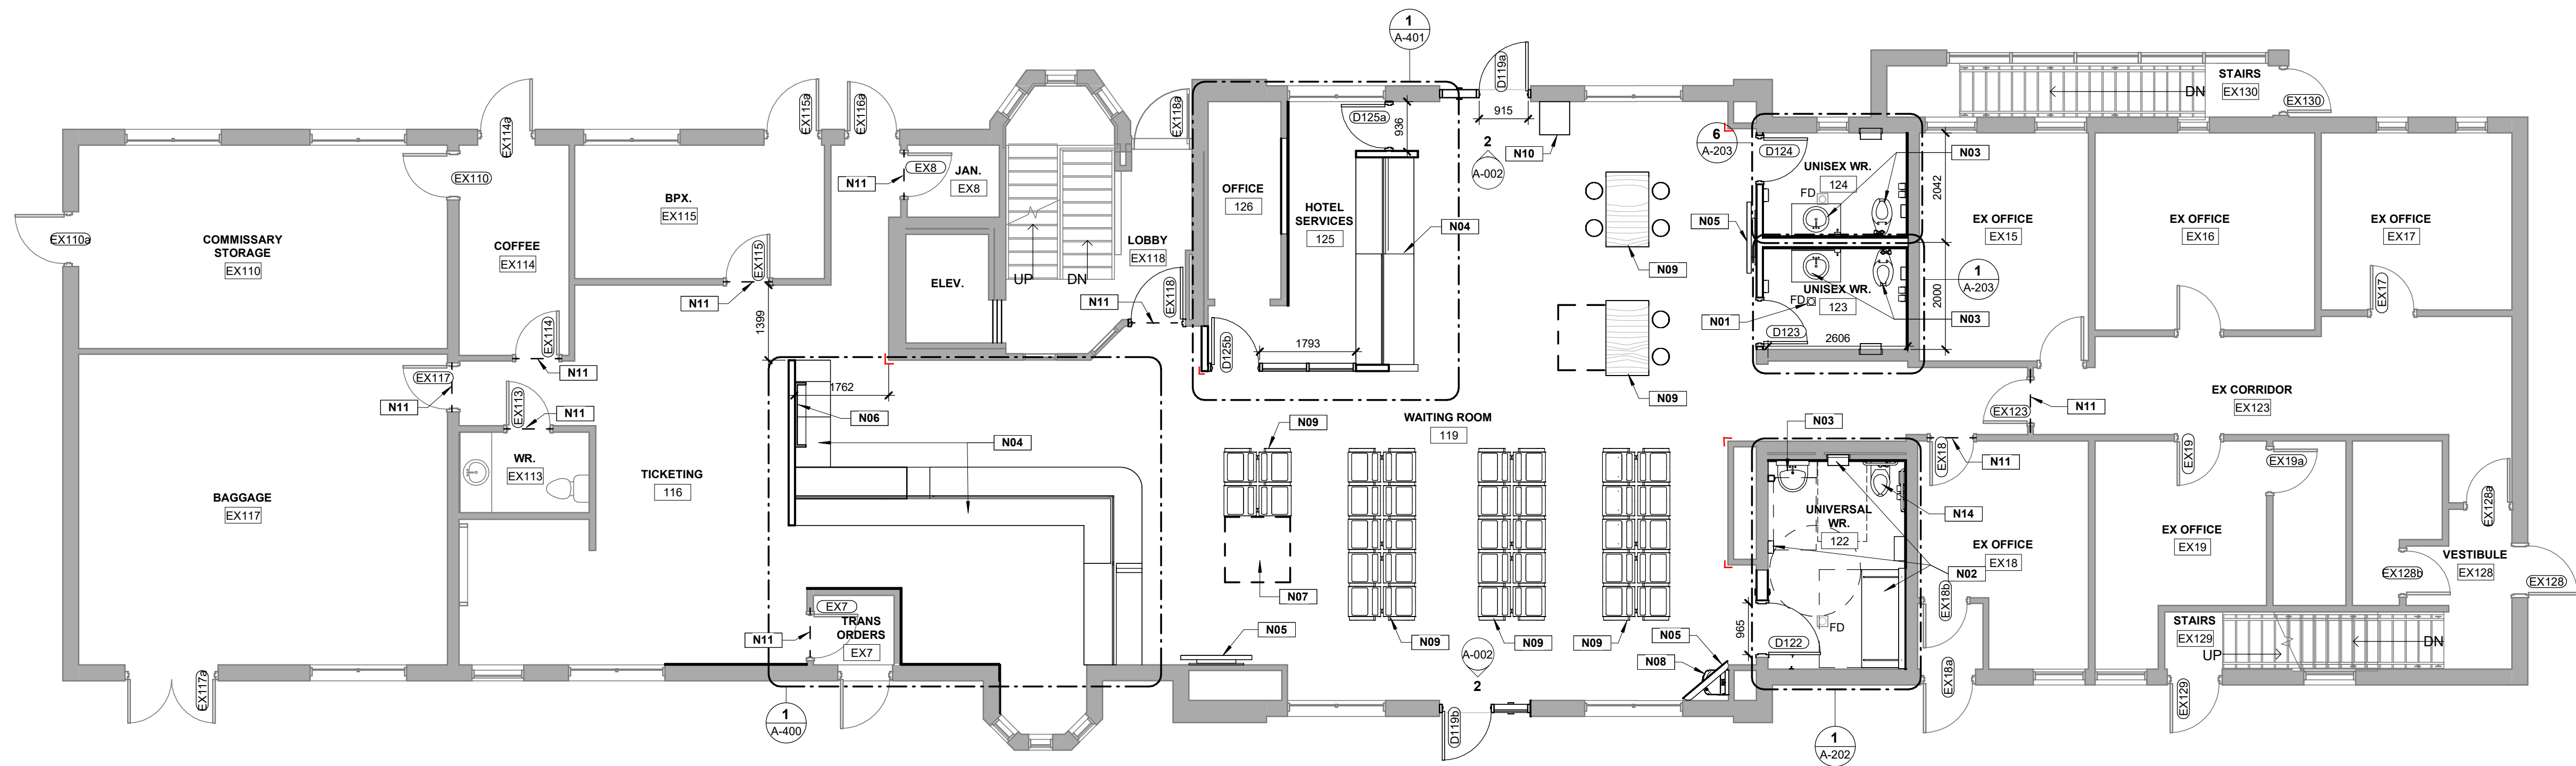

1 MAIN FLOOR - CONSTRUCTION PLAN
A-201 Scale = 1:75

CONSULTANT



CLIENT




COPYRIGHT NOTICE
THIS DRAWING AND DESIGN IS COPYRIGHT PROTECTED.
DO NOT REPRODUCE OR REVISE WITHOUT WRITTEN
PERMISSION BY ARCHITECTURE49 INC.

SEAL:

THIS BAR IS 25mm LONG WHEN PLOTTED AT
CORRECT SCALE. DO NOT SCALE DRAWINGS.

NORTH ARROW: DIGITAL REFERENCE:

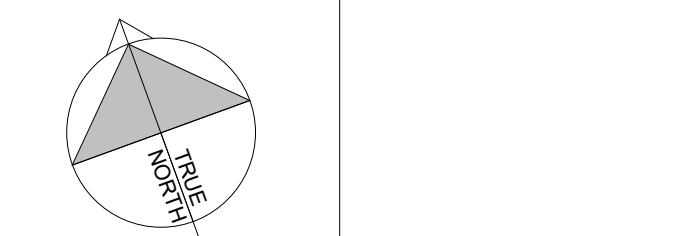

PROJECT NO.: CA0038862 CONTRACT NO. 33328
DRAWN BY: TG/BW CHECKED BY: Checker APPROVED BY: DO
KEYPLAN:

B 2025-06-18 ISSUED FOR TENDER
NO. DATE ISSUED
PROJECT

ONTCAODA DESIGN
COMPLIANCE
Cochrane & Englehart

DRAWING TITLE

COCHRANE GROUND
FLOOR CONSTRUCTION
PLAN

DRAWING NO. A-201

PRINT DATE: 2025-06-16 1:28:15 PM